


M0599
ELEVATOR PENTHOUSE

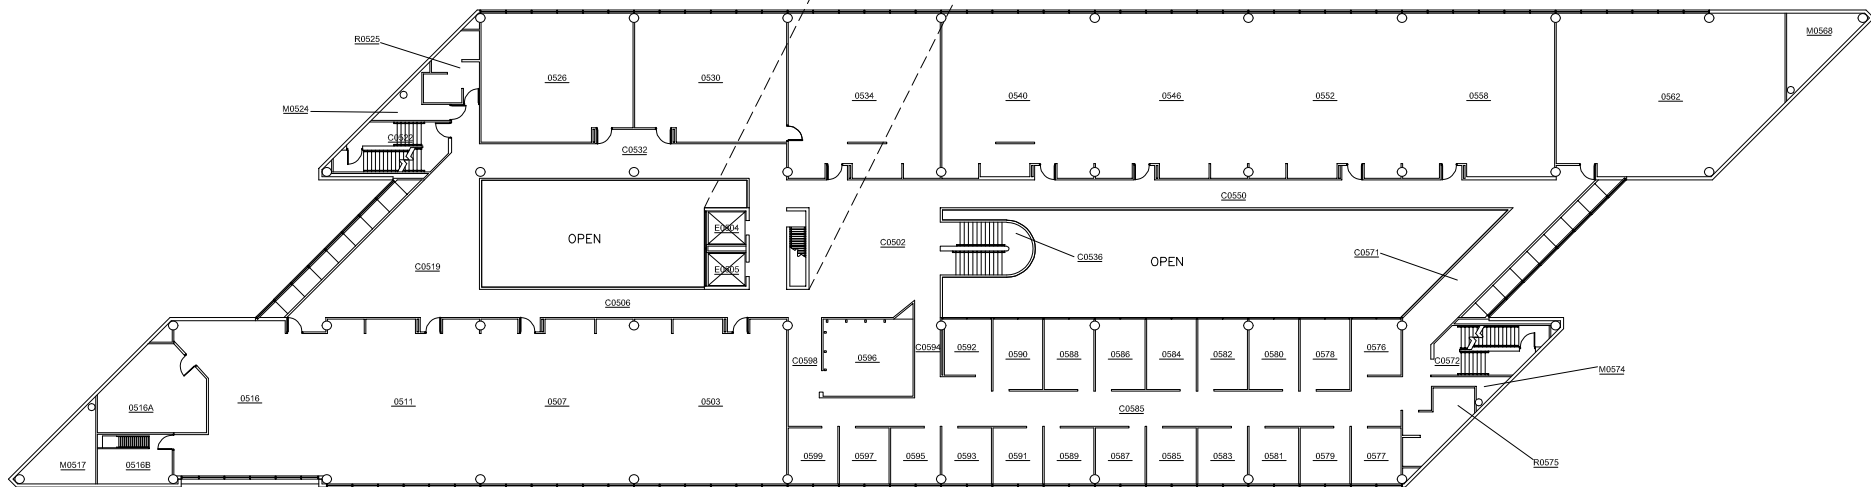

FIFTH FLOOR PLAN

DESIGN, COLLEGE OF
IOWA STATE UNIVERSITY
AMES, IOWA



SCALE 1"=40' 1977

REVISED JAN 2024