


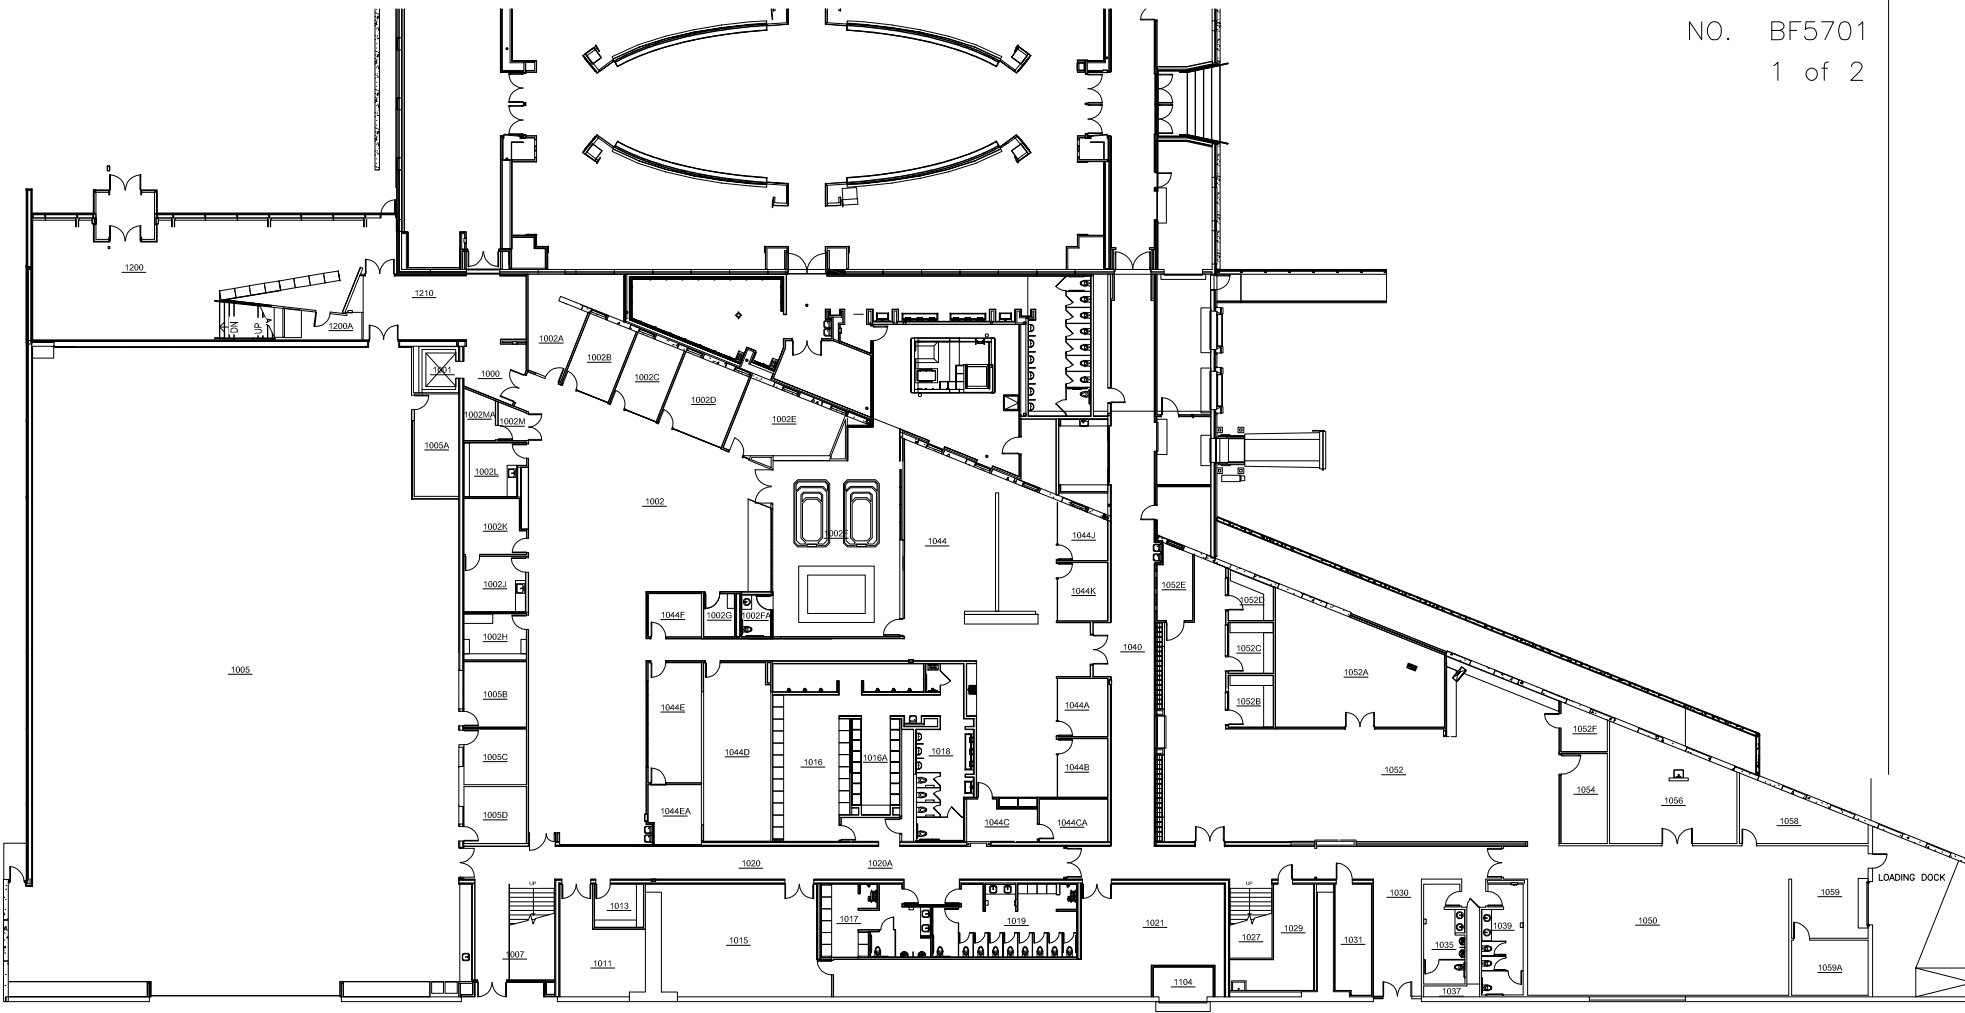

FIRST FLOOR PLAN

BERGSTROM
FOOTBALL COMPLEX
IOWA STATE UNIVERSITY
AMES, IOWA
SCALE 1"=40' 2012
REVISED APR 2022